



TOWNSHIP of HOPEWELL
MERCER COUNTY

201 WASHINGTON CROSSING – PENNINGTON ROAD
TITUSVILLE, NEW JERSEY 08560-1410

PROJECT / APPLICATION

BLOCK:


LOT:

ADDRESS:

PROJECT NAME:

PLANS

Part 4 - Utilities Plans

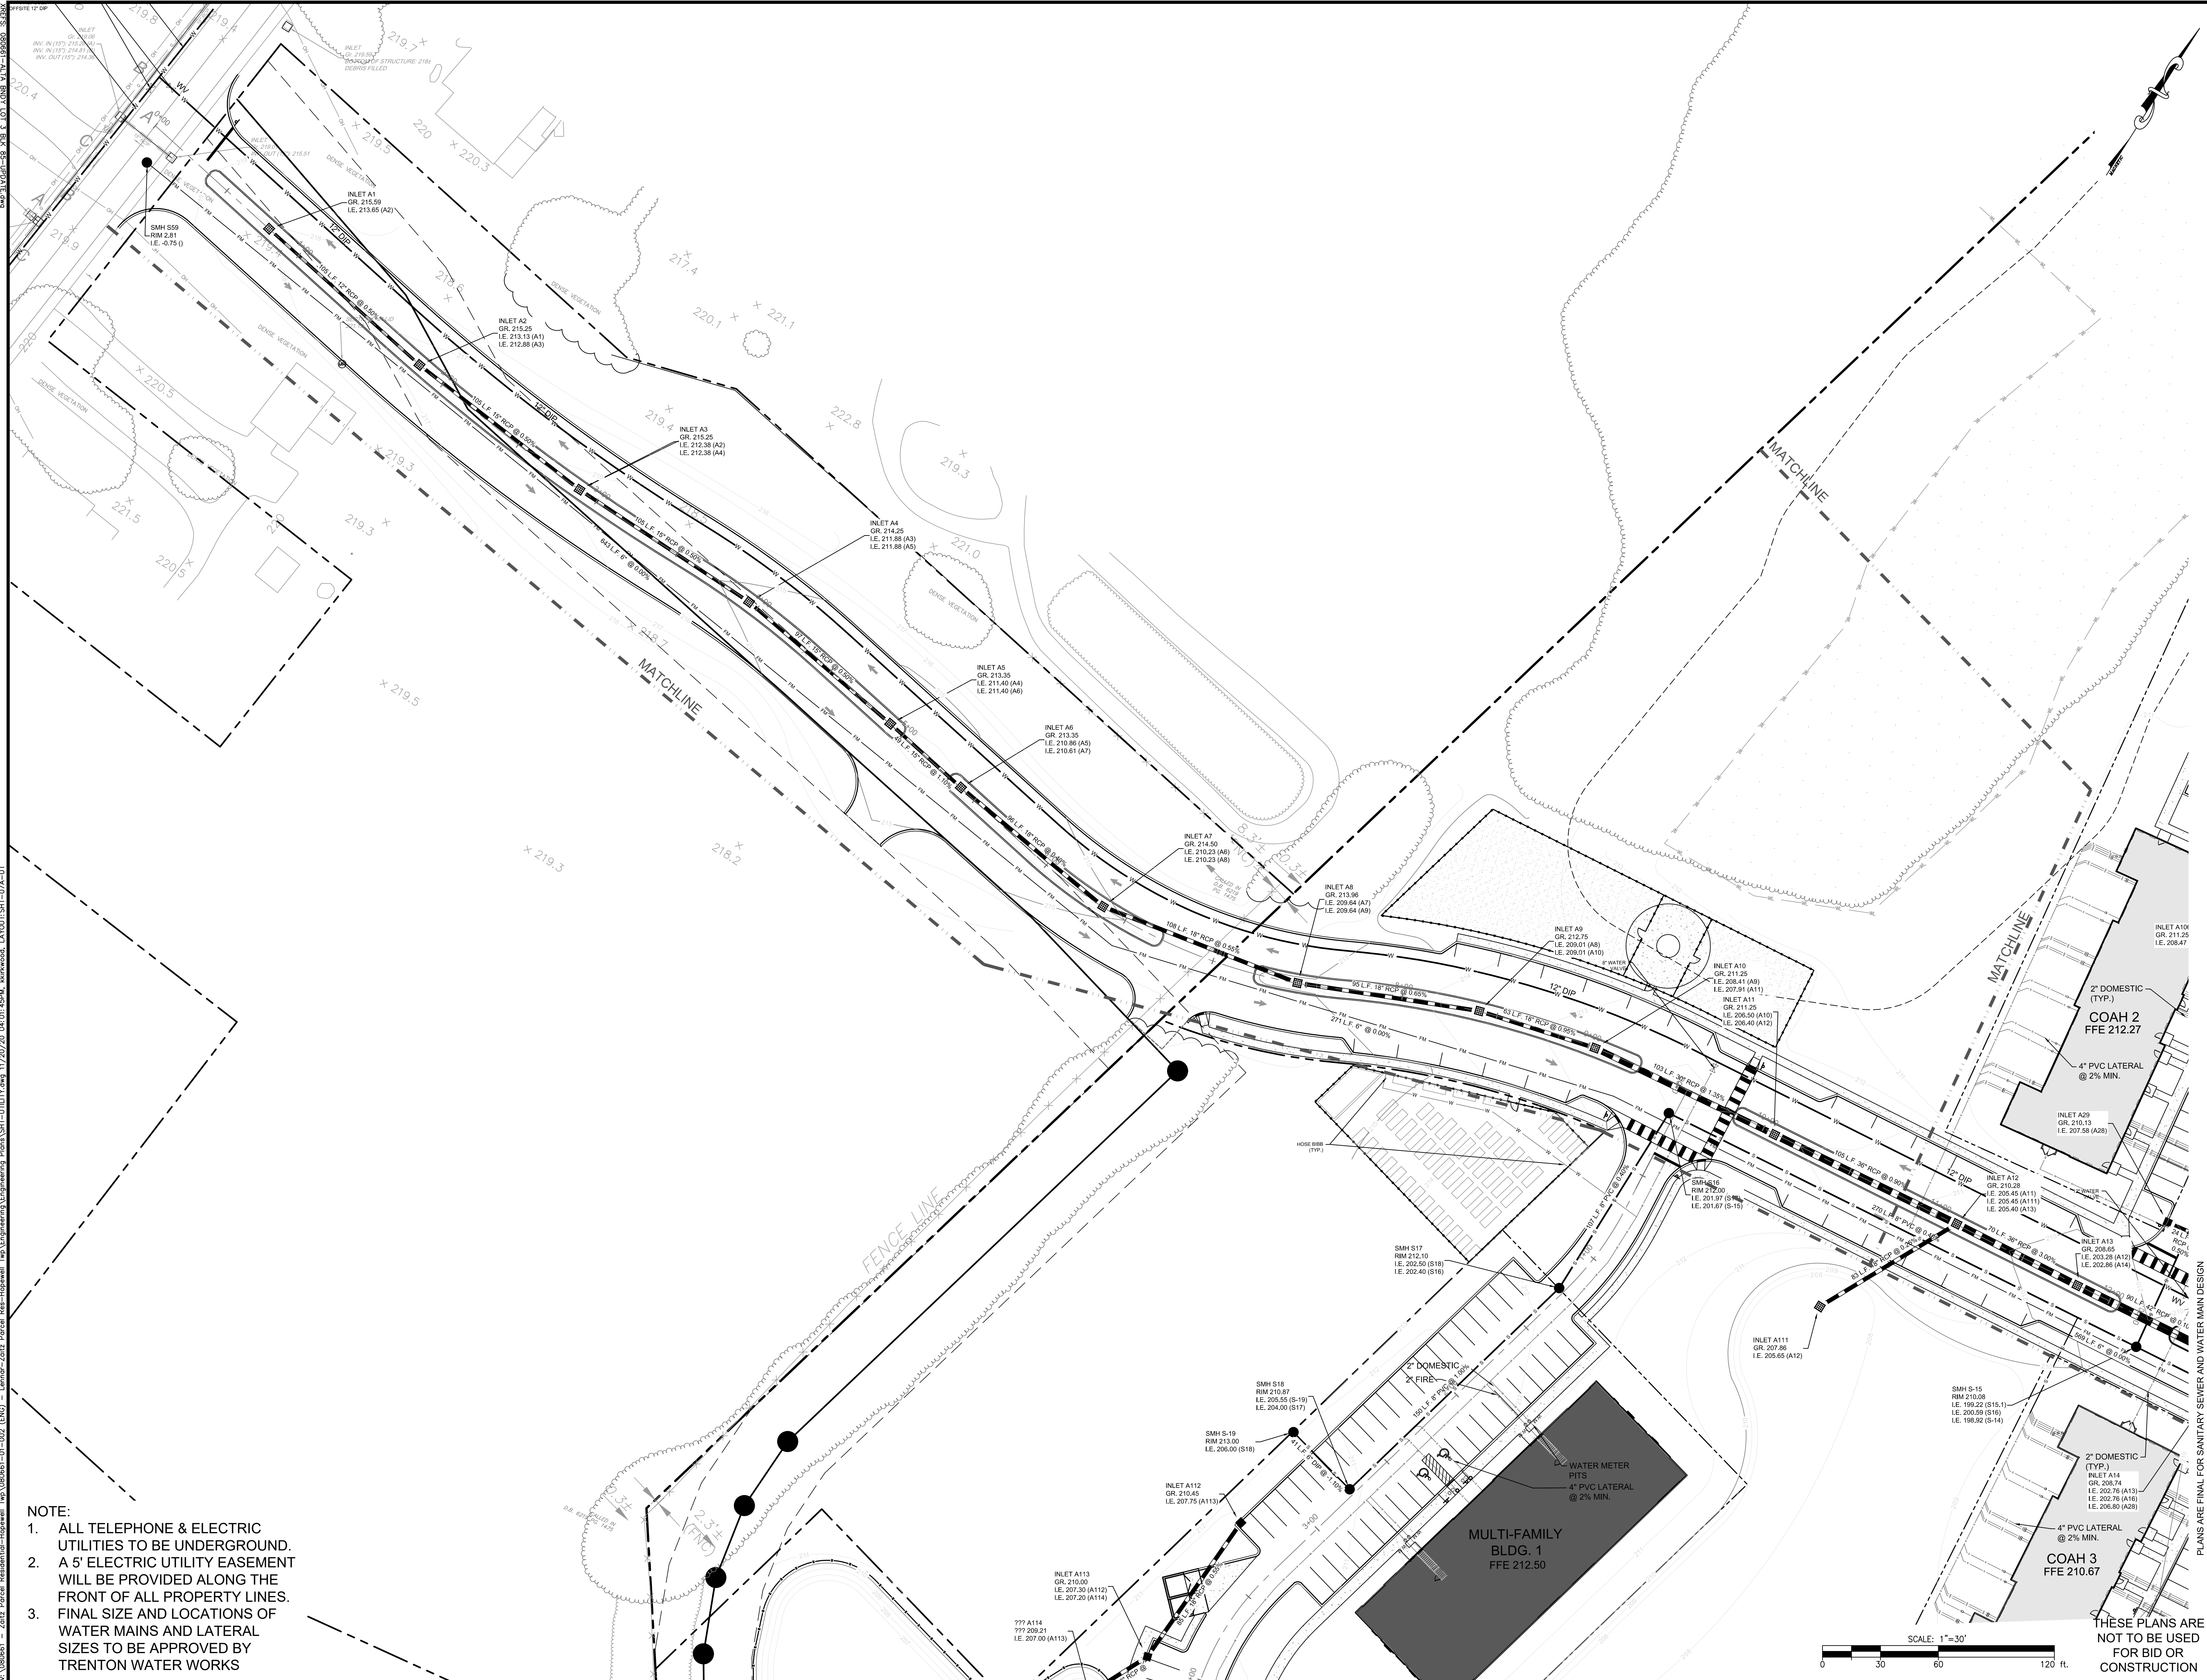

NOTE:

1. ALL TELEPHONE & ELECTRIC UTILITIES TO BE UNDERGROUND.
2. A 5' ELECTRIC UTILITY EASEMENT WILL BE PROVIDED ALONG THE FRONT OF ALL PROPERTY LINES.
3. FINAL SIZE AND LOCATIONS OF WATER MAINS AND LATERAL SIZES TO BE APPROVED BY TRENTON WATER WORKS

SCALE: 1"=30'

0 30 60 120 ft.

THESE PLANS ARE
NOT TO BE USED
FOR BID OR
CONSTRUCTION

PLANS ARE FINAL FOR SANITARY SEWER AND WATER MAIN DESIGN

PRELIMINARY & FINAL MAJOR SUBDIVISION AND PRELIMINARY & FINAL SITE PLAN

THE COLLECTION at HOPEWELL

UTILITIES PLAN

SHEET No. 7 A

BLOCK 85, LOT 3; BLOCK 86, LOTS 32-34 & 130; AND PART OF BLOCK 85, LOT 9
TOWNSHIP OF HOPEWELL, MERCER COUNTY, NEW JERSEY

Phone: 732-665-5500
FAX: 732-665-5501
E-mail: NJ@BowmanConsulting.com
NJ Certificate No. 24-6A98222800

Sh c De

Bowman Consulting Group, Ltd.
303 W. Main Street
Trenton, New Jersey 07728
E-mail: NJ@BowmanConsulting.com

SEAN A. DELANY, N.J. Professional Engineer, Lic. 24C604447100

Bowman
CONSULTING

PROJ.: 080681-F1-001
DATE: 11-20-2020
CHKD: SAD

REVISION	DATE	CHD	REVISION	DATE	CHD
1			7		
2			6		
3			9		
4			10		
5			11		
6			12		

64672147-99999-001-002 (EN) - 2012 Parcel Res-Hopewell, Two (09/06/01-01-002 (EN)) - 1/20/20 04:02:32PM, Jskkwood, LAYOUT-SHT-07B-JUT
V:\090601 - 2012 Parcel Res-Hopewell, Two (09/06/01-01-002 (EN)) - 1/20/20 04:02:32PM, Jskkwood, LAYOUT-SHT-07B-JUT
64672147-99999-001-002 (EN) - 2012 Parcel Res-Hopewell, Two (09/06/01-01-002 (EN)) - 1/20/20 04:02:32PM, Jskkwood, LAYOUT-SHT-07B-JUT
64672147-99999-001-002 (EN) - 2012 Parcel Res-Hopewell, Two (09/06/01-01-002 (EN)) - 1/20/20 04:02:32PM, Jskkwood, LAYOUT-SHT-07B-JUT

- NOTE:
1. ALL TELEPHONE & ELECTRIC UTILITIES TO BE UNDERGROUND.
 2. A 5' ELECTRIC UTILITY EASEMENT WILL BE PROVIDED ALONG THE FRONT OF ALL PROPERTY LINES.
 3. FINAL SIZE AND LOCATIONS OF WATER MAINS AND LATERAL SIZES TO BE APPROVED BY TRENTON WATER WORKS



PROJ: 080614-001
DATE: 1-20-2020
THIS DRAWING AND ALL INFORMATION CONTAINED HEREIN IS THE PROPERTY OF BOWMAN CONSULTING. IT IS TO BE USED ONLY FOR THE PROJECT AND SITE SPECIFICALLY IDENTIFIED HEREON. IT IS NOT TO BE REPRODUCED, COPIED, OR TRANSMITTED IN ANY FORM OR BY ANY MEANS, ELECTRONIC OR MECHANICAL, WITHOUT THE WRITTEN PERMISSION OF BOWMAN CONSULTING. © 2020 BOWMAN CONSULTING

Phone: 732-666-5500
300 N. Main Street, Suite 200
NJ Certificate of Authorization
No. 24-00022606
Email: info@bowmanconsulting.com

SEAN A. DELANY, N.J. Professional Engineer, Lic. 24GE04447100

Bowman Consulting Group, Ltd.
PRELIMINARY & FINAL MAJOR SUBDIVISION AND PRELIMINARY & FINAL SITE PLAN
THE COLLECTION at HOPEWELL
UTILITIES PLAN

THESE PLANS ARE NOT TO BE USED FOR BID OR CONSTRUCTION


SCALE: 1"=30'

7
B

REVISION	DATE	BY
1		
2		
3		
4		
5		
6		
7		

V:\080661 - Zoltz Parcel Residential-Hopewell_Twp\080661-01-102 (E10) - Lerner-Zoltz Parcel Res-Hopewell_Twp\Engineering\Engineering Plans\SH-UTILITY.dwg, 11/20/20, 04:03:58PM, Jskkwood, LAYOUT-SHT-07D-UT

- NOTE:
1. ALL TELEPHONE & ELECTRIC UTILITIES TO BE UNDERGROUND.
 2. A 5' ELECTRIC UTILITY EASEMENT WILL BE PROVIDED ALONG THE FRONT OF ALL PROPERTY LINES.
 3. FINAL SIZE AND LOCATIONS OF WATER MAINS AND LATERAL SIZES TO BE APPROVED BY TRENTON WATER WORKS

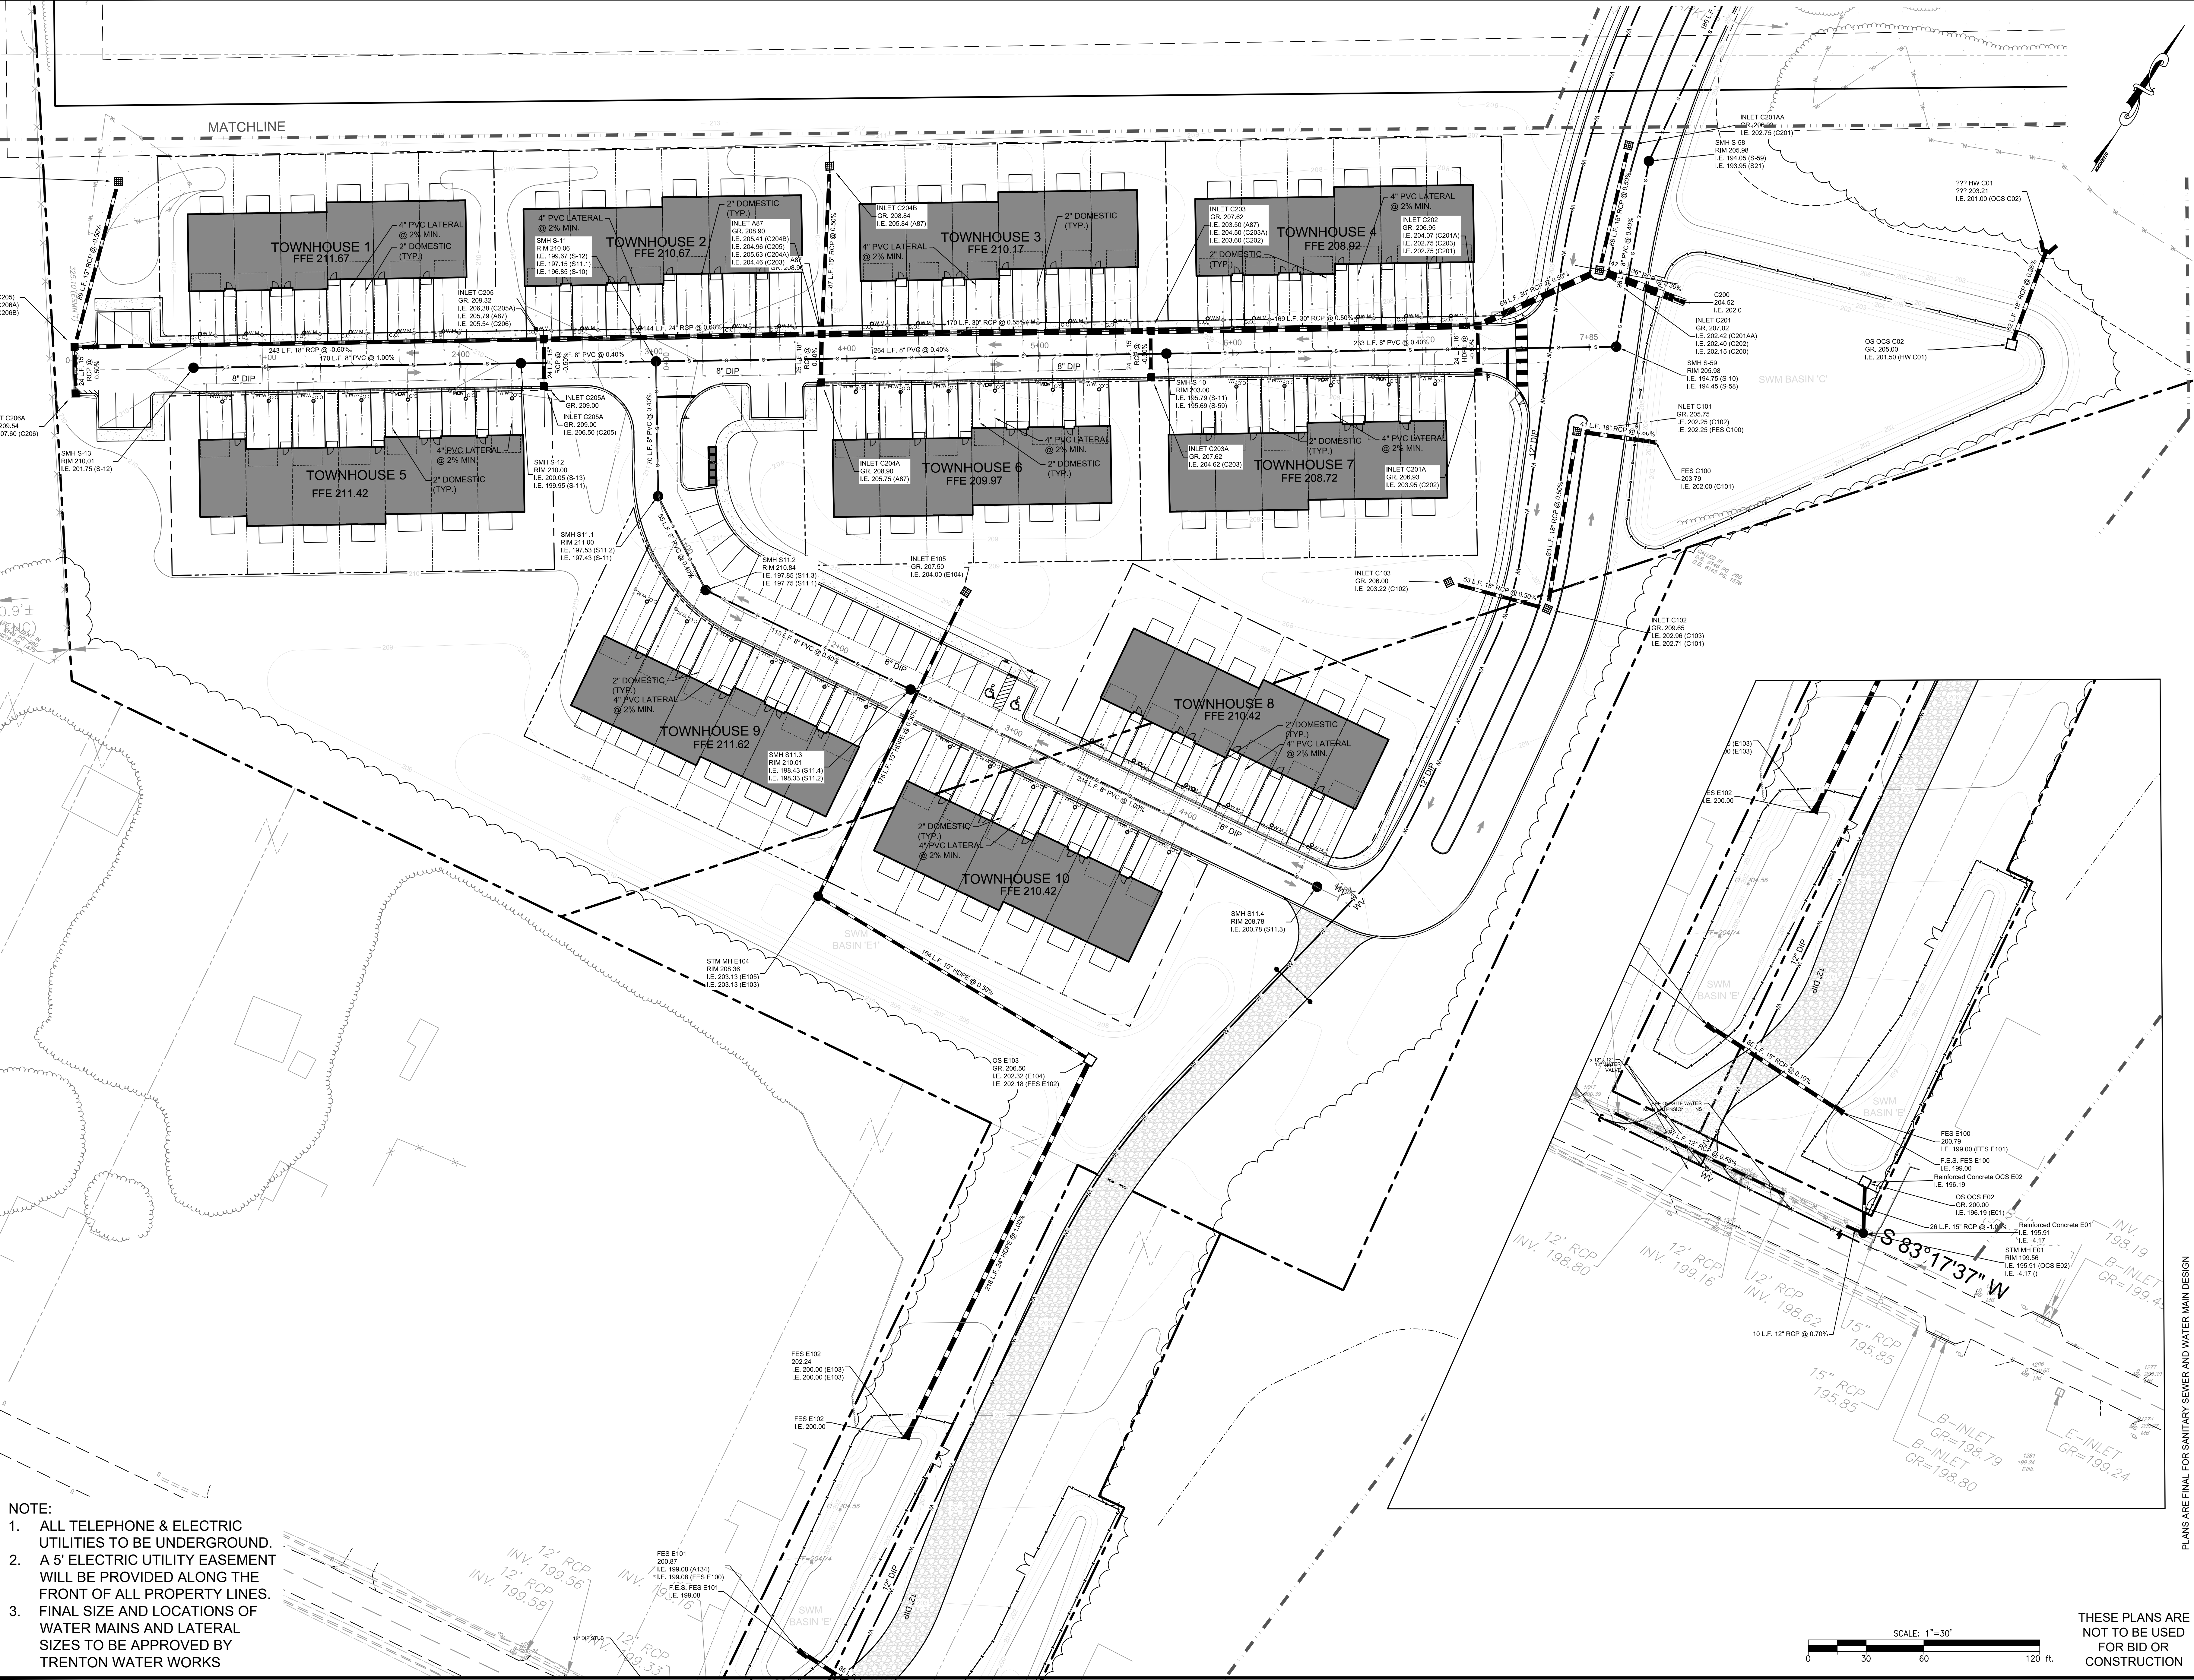

PROJ.: 080661-01-102
DATE: 11-20-2020
THIS DRAWING AND ALL INFORMATION CONTAINED HEREIN ARE THE PROPERTY OF BOWMAN CONSULTING GROUP, LLC. NO PART OF THIS DRAWING IS TO BE REPRODUCED OR TRANSMITTED IN ANY FORM OR BY ANY MEANS, ELECTRONIC OR MECHANICAL, WITHOUT PERMISSION IN WRITING FROM BOWMAN CONSULTING GROUP, LLC. © 2020 BOWMAN CONSULTING GROUP, LLC. ALL RIGHTS RESERVED.

6

5

4

3

2

1

REVISION

DATE

CHD

Bowman
CONSULTING

Phone: 732-665-5500
303 N. Main Street, Suite 277B
Hopewell, NJ 08061
www.bowmanconsulting.com
Email: info@bowmanconsulting.com
NJ Certificate of Authorization
No. 24-022226-000


Sean A. Delany
SEAN A. DELANY, N.J. Professional Engineer, Lic. 24GE04447100

PRELIMINARY & FINAL MAJOR SUBDIVISION AND PRELIMINARY & FINAL SITE PLAN
THE COLLECTION at HOPEWELL
UTILITIES PLAN
BLOCK 66, LOT 3, BLOCK 66, LOTS 32-34 & 130; AND PART OF BLOCK 65, LOT 9
TOWNSHIP OF HOPEWELL, MERCER COUNTY, NEW JERSEY

SHEET No.
7
OF
D


PLANS ARE FINAL FOR SANITARY SEWER AND WATER MAIN DESIGN

THESE PLANS ARE NOT TO BE USED FOR BID OR CONSTRUCTION

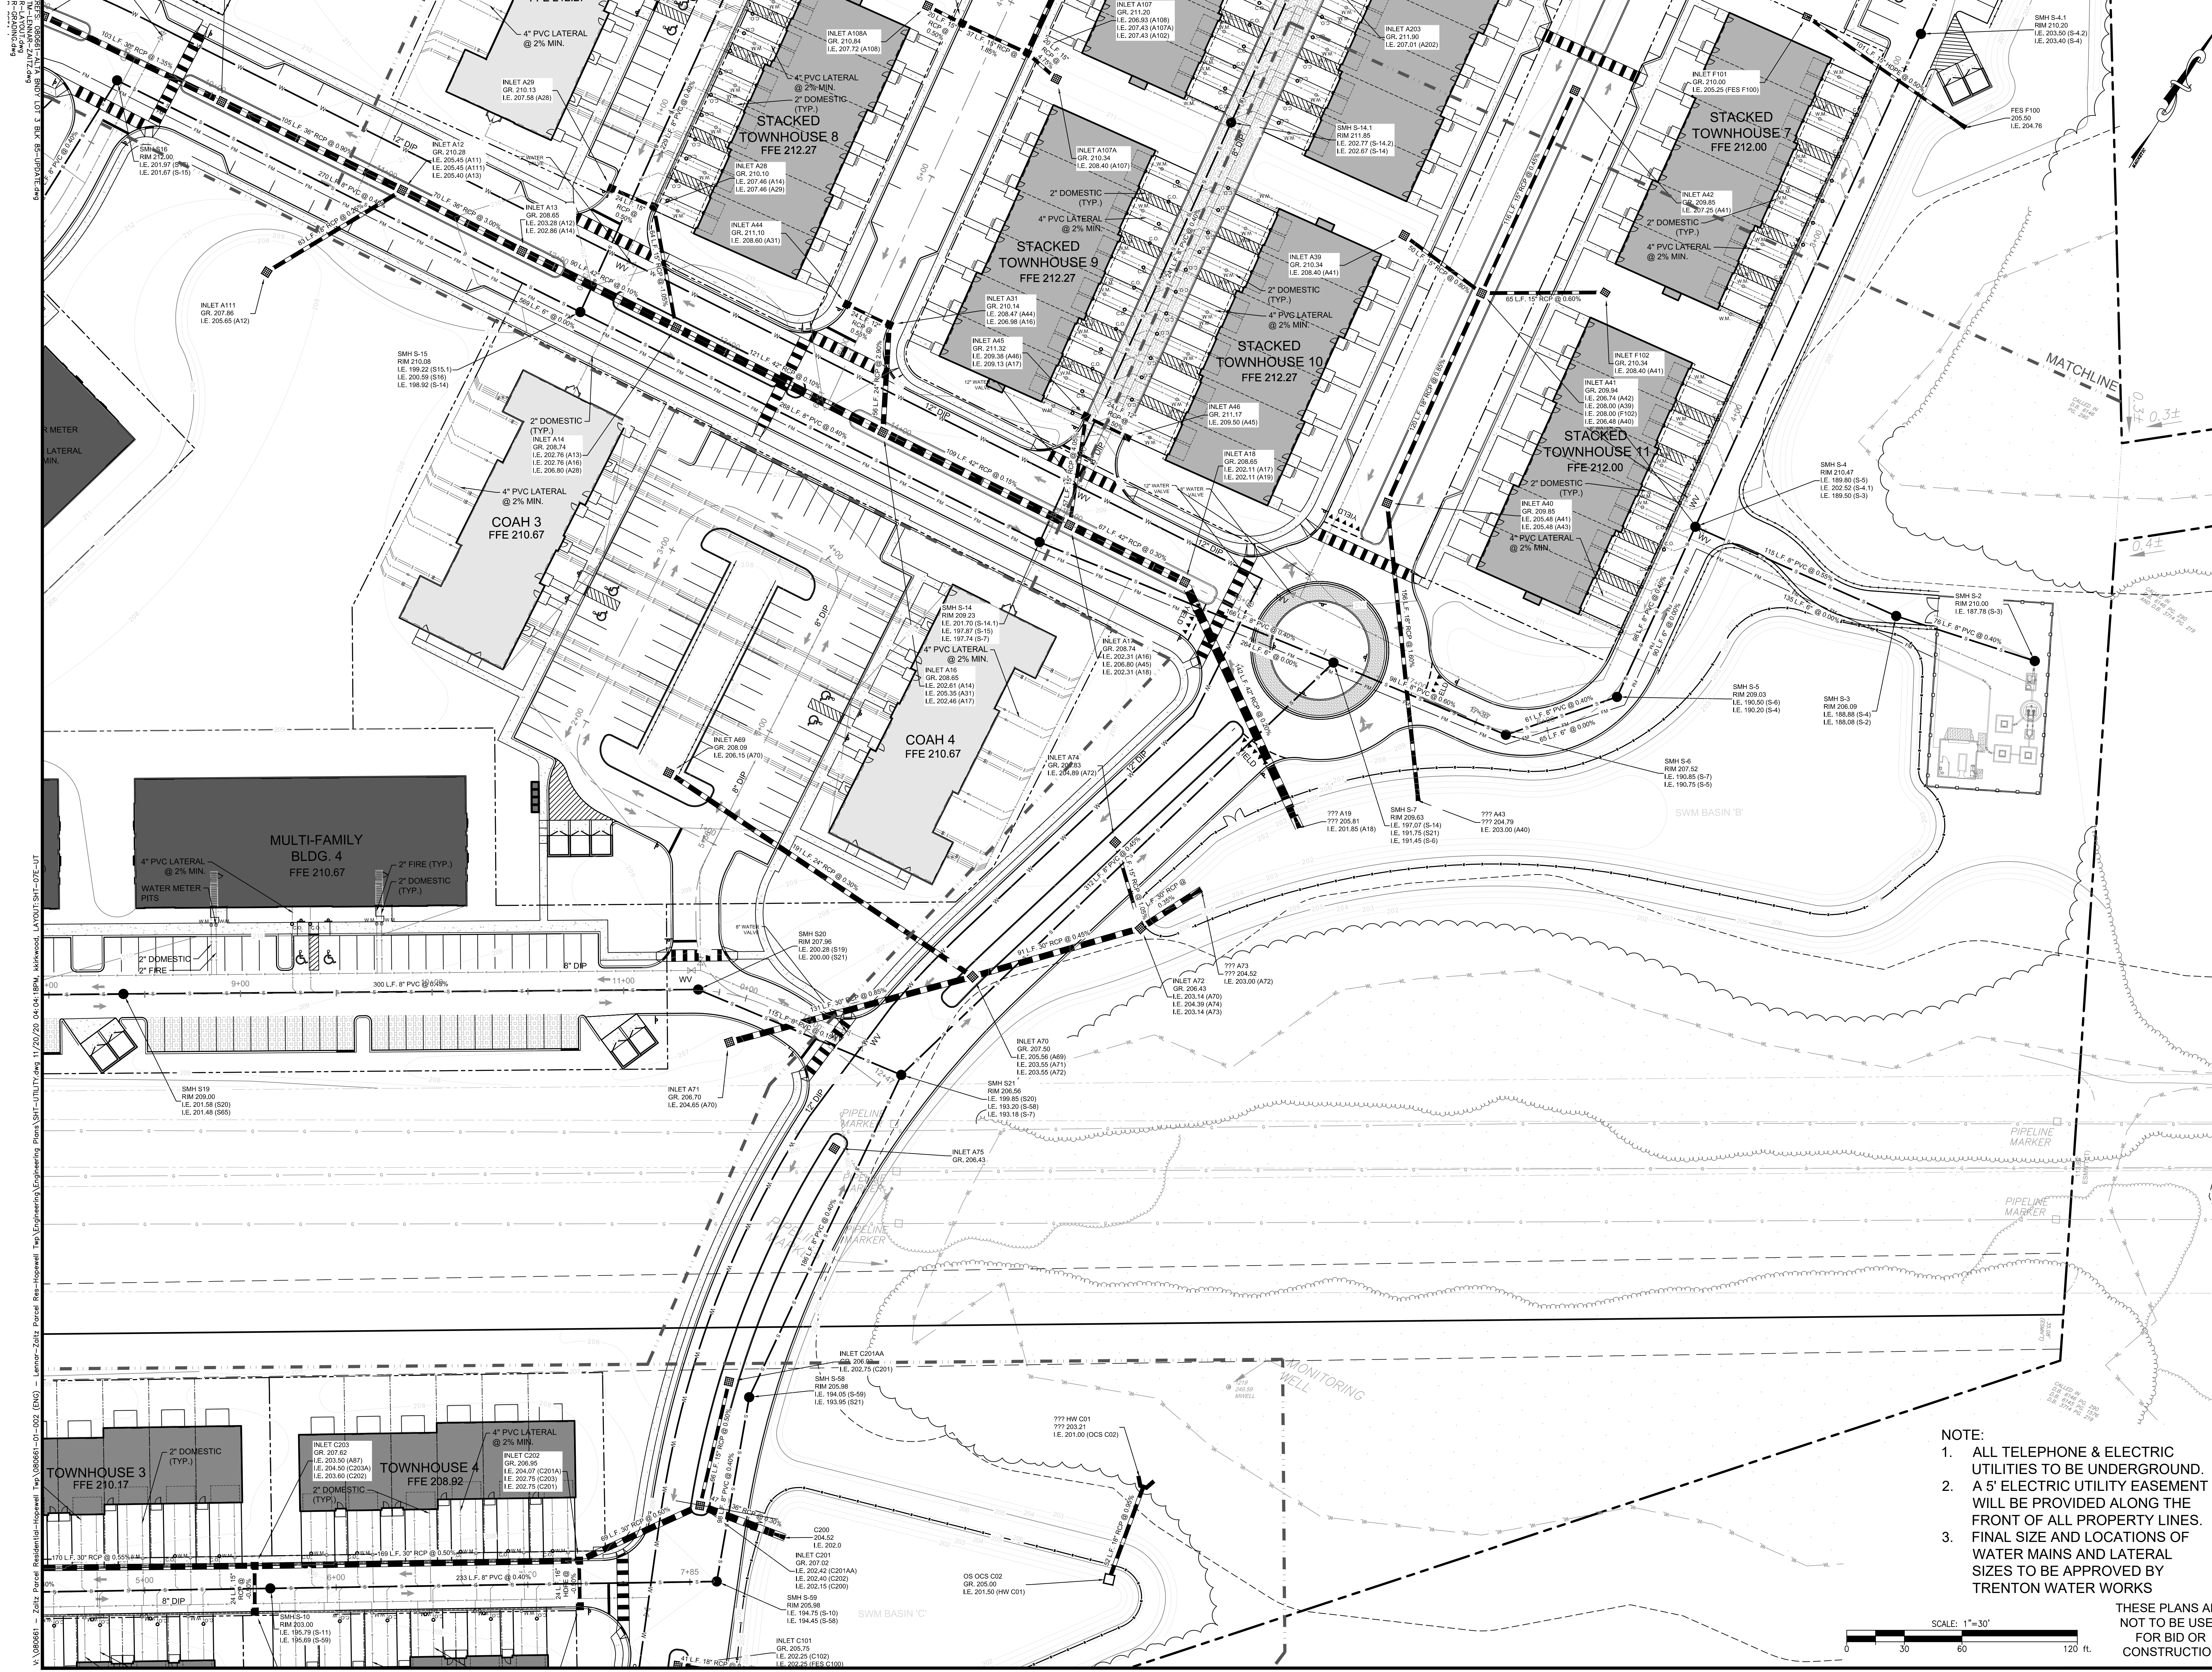

NOTE:

1. ALL TELEPHONE & ELECTRIC UTILITIES TO BE UNDERGROUND.
2. A 5' ELECTRIC UTILITY EASEMENT WILL BE PROVIDED ALONG THE FRONT OF ALL PROPERTY LINES.
3. FINAL SIZE AND LOCATIONS OF WATER MAINS AND LATERAL SIZES TO BE APPROVED BY TRENTON WATER WORKS

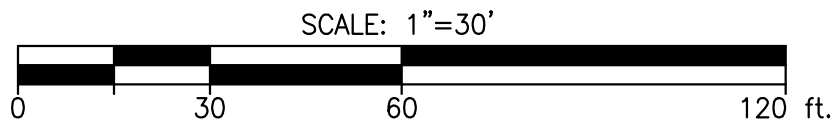

THESE PLANS ARE
NOT TO BE USED
FOR BID OR
CONSTRUCTION

PLANS ARE FINAL FOR SANITARY SEWER AND WATER MAIN DESIGN

PRELIMINARY & FINAL MAJOR SUBDIVISION AND PRELIMINARY & FINAL SITE PLAN
THE COLLECTION at HOPEWELL
UTILITIES PLAN

SHEET No.
7
OF
E

Bowman Consulting Group, Ltd.
300 N. Main Street
Trenton, NJ 08646
www.bowmanconsulting.com
Email: info@bowmanconsulting.com
Phone: 732-666-5500
Fax: 732-666-5501
NJ Certificate of Authorization
No. 24-002226-000

Sean A. Delany

SEAN A. DELANY, N.J. Professional Engineer, Lic. 24GE0447100

Bowman
CONSULTING

PROJ.: 08061-H-001
DATE: 1-20-2020
THIS DRAWING AND ALL INFORMATION CONTAINED HEREIN IS THE PROPERTY OF BOWMAN CONSULTING GROUP, LTD. IT IS TO BE USED ONLY FOR THE PROJECT AND SITE SPECIFICALLY IDENTIFIED HEREON. NO PART OF THIS DRAWING IS TO BE REPRODUCED OR TRANSMITTED IN ANY FORM OR BY ANY MEANS, ELECTRONIC OR MECHANICAL, WITHOUT THE WRITTEN PERMISSION OF BOWMAN CONSULTING GROUP, LTD.

NO.	REVISION	DATE	BY
1			
2			
3			
4			
5			
6			
7			
8			
9			
10			
11			
12			
13			